

# OGDEN SCHOOL DISTRICT

1950 MONROE BLVD  
OGDEN, UTAH 84401



## MOUND FORT MIDDLE SCHOOL STAGE LIGHTING CONTROLS UPGRADE

**BNA**  
CONSULTING  
SALT LAKE ST. GEORGE

4225 Lake Park Blvd. Ste. 275  
West Valley City, Utah 84120  
P.801.532.2196  
www.bnacconsulting.com



**MOUND FORT  
MIDDLE SCHOOL  
1400 MOUND FORT DRIVE  
OGDEN, UTAH 84404**

INDEX OF DRAWINGS	
COVER SHEET	
E100: SYMBOLS, SCHEDULES, NOTES AND RISER DIAGRAMS	
E101: ELECTRICAL DEMOLITION PLAN - AUDITORIUM AREA	
E101: ELECTRICAL PLAN - AUDITORIUM AREA	





ISSUE	DATE	DESCRIPTION


DATE:	JUNE 2024
PROJECT NO.:	24-018
DRAWN BY:	BNA
CHECKED BY:	
SCALE:	1:1

ELECTRICAL DEMOLITION PLAN  
 AUDITORIUM AREA  
 E101

**SHEET KEYNOTES**

01 - ALL DEMOLITION SHALL BE IN ACCORDANCE WITH THE OGDEN SCHOOL DISTRICT DEMOLITION MANUAL TO THE 2018 INTERNATIONAL RESIDENTIAL CODE BOOK, AS AMENDED BY LOCAL ORDINANCES AND CITY ORDINANCES. ALL LOCAL ORDINANCES SHALL BE OBTAINED FROM THE OGDEN SCHOOL DISTRICT ENGINEERING DEPARTMENT. SEE THE DEMOLITION MANUAL FOR A COMPLETE LIST OF DEMOLITION PROCEDURES. THE ENGINEER'S CONTRACT MAY BE REFERRED TO FOR A COMPLETE LIST OF DEMOLITION PROCEDURES.


02 - EXISTING CONDITIONS TO BE DEMOLISHED AND JUNCTION BOXES COVERED.

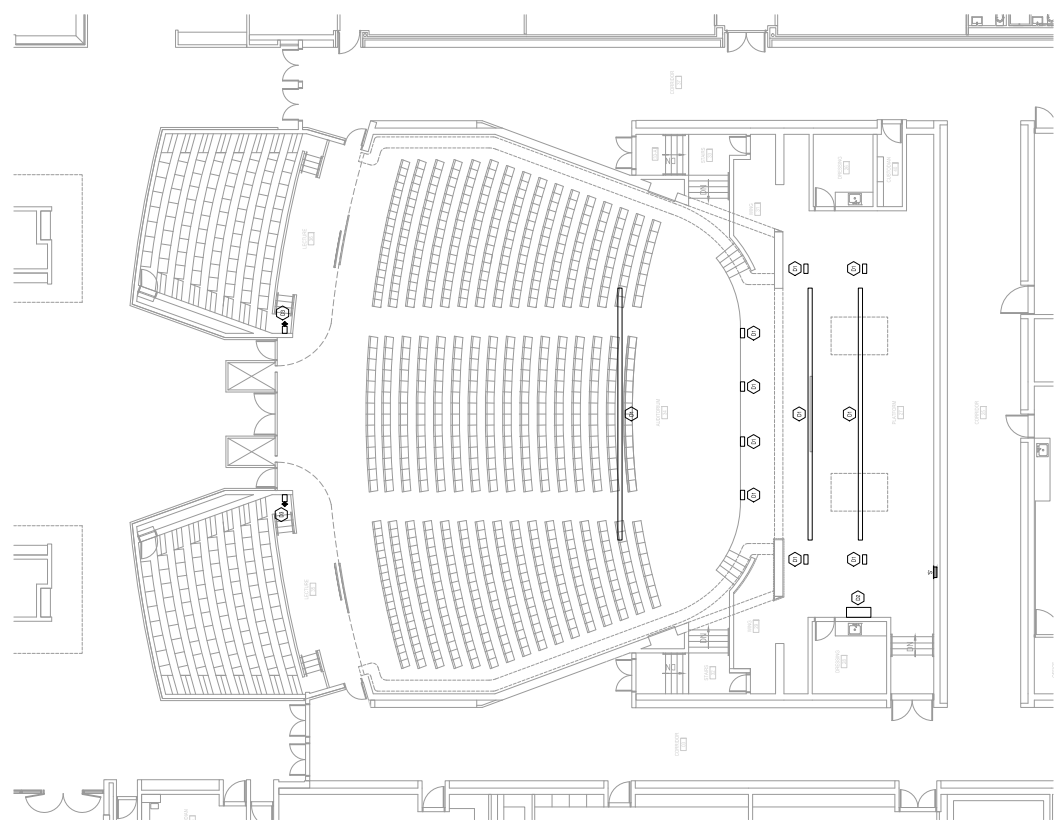

ELECTRICAL DEMOLITION PLAN  
 AUDITORIUM AREA  
 1/4" = 1'-0"

**SHEET KEYNOTES**

- E1: PROVIDE NEW WIRING AND PANELS TO CORRELATE TO THE EXISTING WIRING AND PANELS. PROVIDE NEW WIRING AND PANELS TO CORRELATE TO THE EXISTING WIRING AND PANELS.
- E2: PROVIDE NEW WIRING AND PANELS TO CORRELATE TO THE EXISTING WIRING AND PANELS. PROVIDE NEW WIRING AND PANELS TO CORRELATE TO THE EXISTING WIRING AND PANELS.
- E3: PROVIDE NEW WIRING AND PANELS TO CORRELATE TO THE EXISTING WIRING AND PANELS. PROVIDE NEW WIRING AND PANELS TO CORRELATE TO THE EXISTING WIRING AND PANELS.

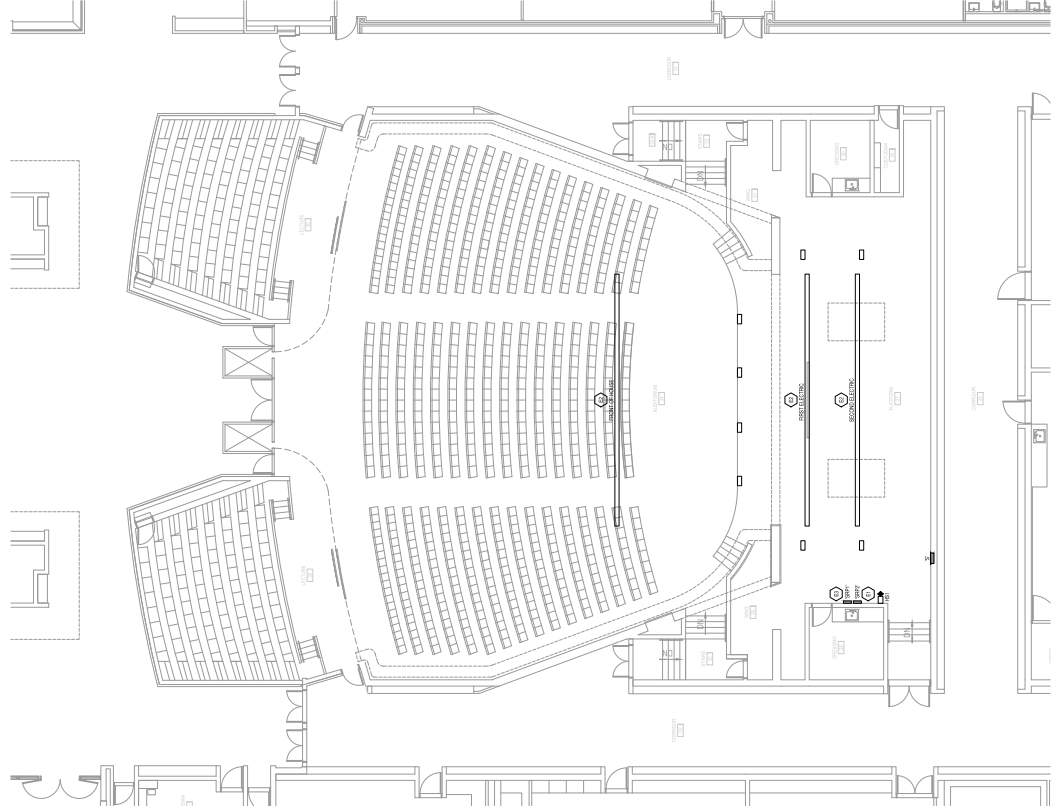

ELECTRICAL PLAN  
AUDITORIUM AREA  
1/8\"/>



NO.	DATE	DESCRIPTION

DATE:	JUNE 2024
PROJECT NO.:	24-001
DRAWN BY:	BNA
CHECKED BY:	BNA

ELECTRICAL PLAN  
AUDITORIUM AREA

E102