

The Designer, contractor, and others, who are preparing this document warrant that the information contained herein is true and correct to the best of their knowledge and belief. The Designer shall not be responsible for any errors or omissions in this document. The Designer shall not be responsible for any errors or omissions in this document. The Designer shall not be responsible for any errors or omissions in this document.

REVISIONS:

DATE:	DESCRIPTION:

KITCHEN & SERVING FOOD SERVICE EQUIPMENT PLUMBING AND ELECTRICAL REQUIREMENT PLANS

MOUND FORT JUNIOR HIGH SCHOOL - OGDEN SCHOOL DISTRICT
SERVING LINE REMODEL
1525 W. 2960 S.
OGDEN, UTAH
BID DOCUMENTS

DATE: MAY 18, 2021
DRAWN BY: RCJ
FILE: FS1.1
JOB #: #JD-2021-596

SHEET: **FS1.2**

ELECTRICAL NOTES

- ELECTRICAL PLAN SHOWS ROOM-IN POINTS AND SCHEDULED CONNECTIONS. DRAWINGS FOR CONSTRUCTION.
- ELECTRICAL SYSTEM IS DESIGNED FOR 120/208V, VOLT, 1-PHASE, 60, HERTZ, 4-WIRE SYSTEM.
- ELECTRICAL BRANCHED SHALL INCLUDE AND INSTALL ALL UNIFORM BOXES EXCEPT WHERE NOTED. RECEPTACLES AND COVER PLATES SHALL BE EXPOSED 3/16" THICK STEEL FINISHED BY ELECTRICAL DIVISION.
- ELECTRICAL BRANCHED SHALL PROVIDE MINIMUM WALL FINISH TO PROVIDE MINIMUM WALL FINISH IF REQUIRED.

ELECTRICAL LEGEND

ELECTRICAL OUTLET

STUD FROM FLOOR

NOTE: ELECTRICAL MOUNTING ARE TO BE FLUSH MOUNTED IN WALLS WITH NO EXPOSED CONDUIT. PROVIDE MINIMUM WALL FINISH IF REQUIRED.

ELECTRICAL ROUGH-IN/FINAL CONNECTION SCHEDULE

ROOM-IN TYPE	SIZE	HGT	#	FIN #	ROOM IN DESCRIPTION	W/CONTR	UNO	CON	REMARKS
ROUGH-IN ELECTRICAL	2"	10"	10	10	100/200/200/200 200 200	120/208V	21	21	RECEIVE ELECTRICAL CONNECTIONS
ROUGH-IN ELECTRICAL	2"	10"	10	10	100/200/200/200 200 200	120/208V	21	21	RECEIVE ELECTRICAL CONNECTIONS

NOTE: PROVIDE DATA CONDUIT AS REQUIRED BY THE SUPPLIER. VERIFY INTERCONNECTION REQUIREMENTS BETWEEN COMPANIES OF STEEL. NOTE: FIN. REM. FROM SHIMMED DOWN TO OUTLET MOUNTED IN COUNTER BASE.

PLUMBING NOTES


- PLUMBING PLANS SHOW ROOM-IN POINTS AND SCHEDULED CONNECTIONS. DRAWINGS FOR CONSTRUCTION.
- PLUMBING DIVISION SHALL FINISH AND INSTALL ALL NECESSARY VALVES, TRAPS, VAL PIECES, LINE STRAINERS, WATER PRESSURE REDUCING DEVICES, AND WASTE LINES TO FOOD SERVICE AND SERVICE EQUIPMENT.
- PLUMBING DIVISION SHALL FINISH AND INSTALL ALL FLOOR SINKS AND FLOOR DRAIN SINKS PROVIDE MINIMUM CLEAN-OUT FOR DRAIN LINES.
- FLOOR SINKS SHALL BE INSTALLED FLUSH WITH FINISH FLOOR OR PER LOCAL CODE WITH REMOVABLE GRATE COVER AS INDICATED.
- FLOOR DRAINS INDICATED ARE FOR FOOD AND SERVICE AREAS ONLY. PLUMBING ENGINEER/ ARCHITECT.

PLUMBING LEGEND

INDIRECT WASTE DRAIN

FLOOR SINK WITH 1/2 GRATE COVER

NOTE: PLUMBING MOUNTING ALL WALL MOUNT PLUMBING UTILITIES ARE TO BE FLUSH MOUNTED IN WALLS WITH NO EXPOSED CONDUIT. PROVIDE MINIMUM WALL FINISH IF REQUIRED.


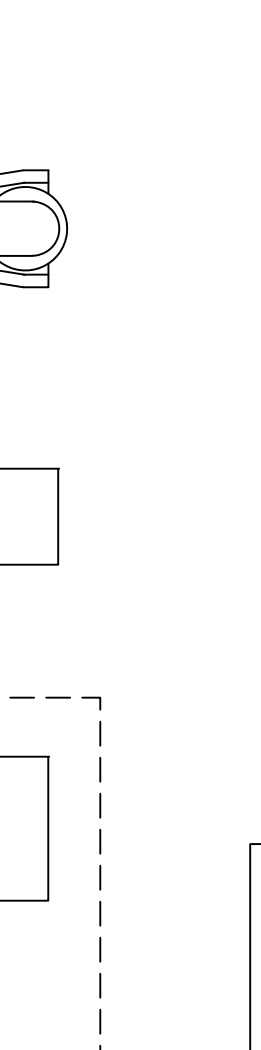


NOTE: PLUMBING COORDINATION KITCHEN EQUIPMENT CONNECTION TO SERVICE AND GENERAL CONTRACTOR FINISHED STRUCTURAL ELEMENTS THROUGH FLOOR.

PLUMBING ROUGH-IN/FINAL CONNECTION SCHEDULE

ROOM-IN TYPE	SIZE	HGT	#	FIN #	ROOM IN DESCRIPTION	W/CONTR	UNO	CON	REMARKS
ROUGH-IN PLUMBING	2"	10"	10	10	100/200/200/200 200 200	120/208V	21	21	RECEIVE PLUMBING CONNECTIONS
ROUGH-IN PLUMBING	2"	10"	10	10	100/200/200/200 200 200	120/208V	21	21	RECEIVE PLUMBING CONNECTIONS

NOTE: PROVIDE INDIRECT WASTE DRAIN TO FLOOR SINK.

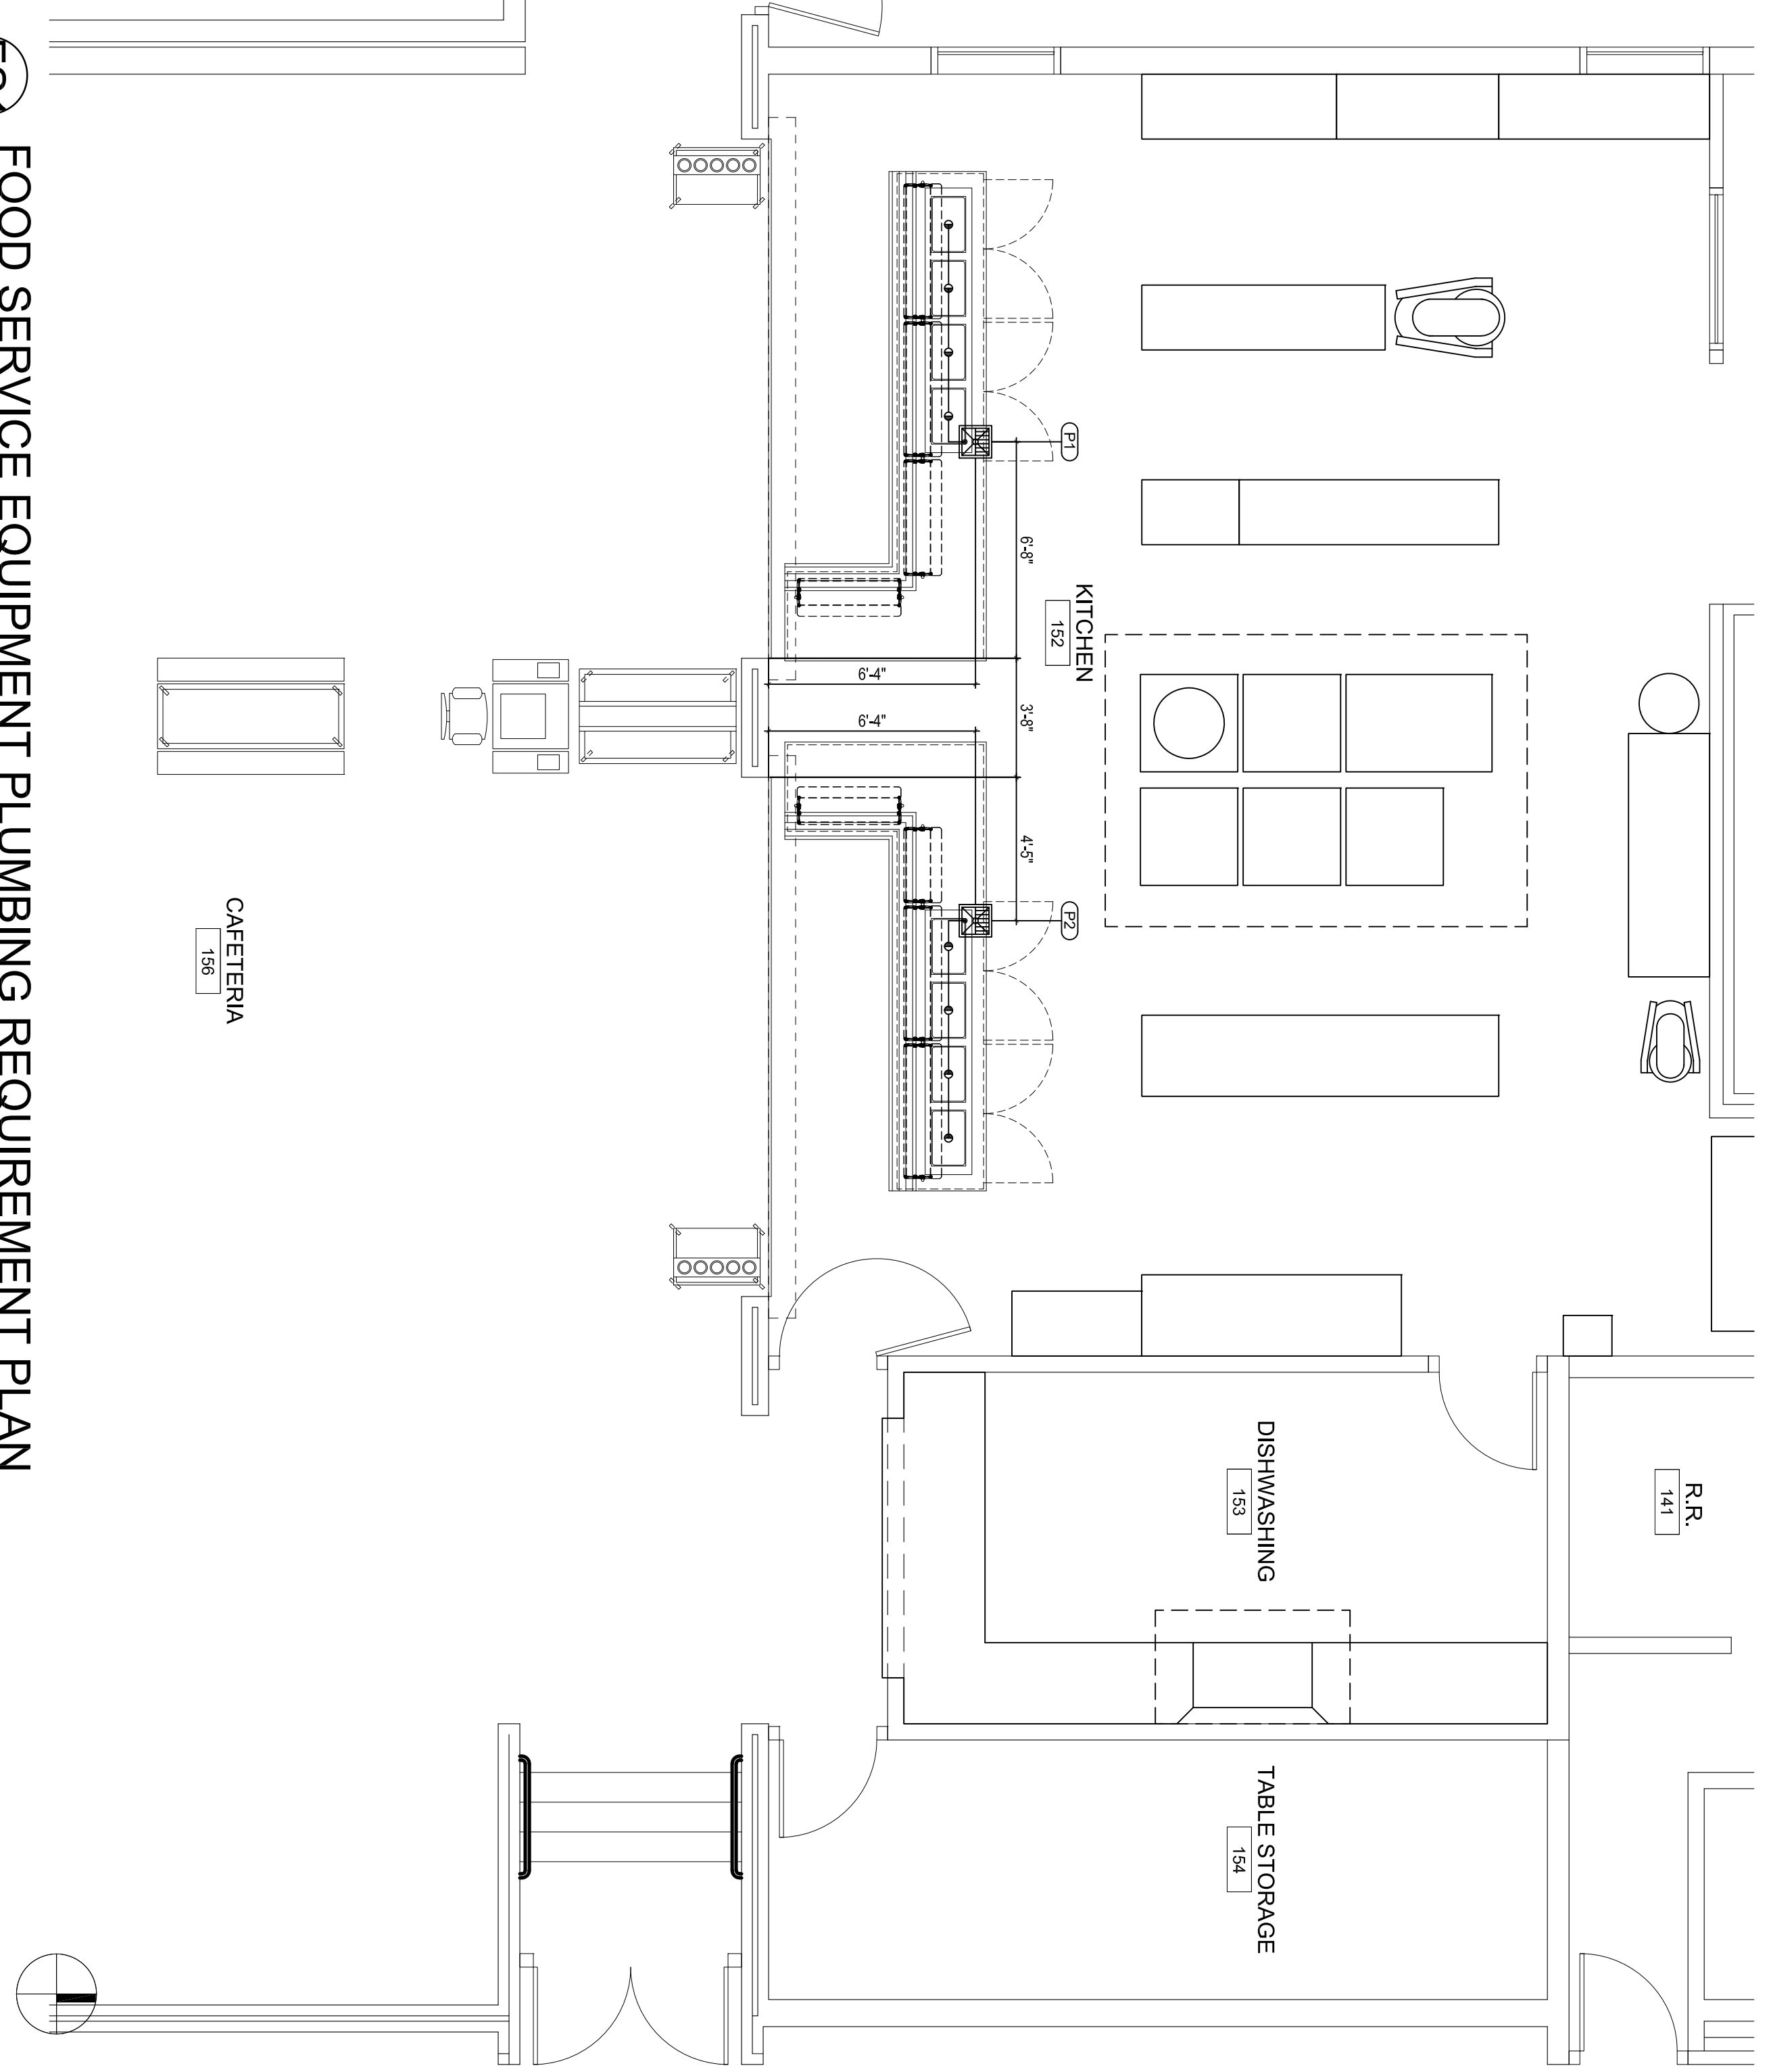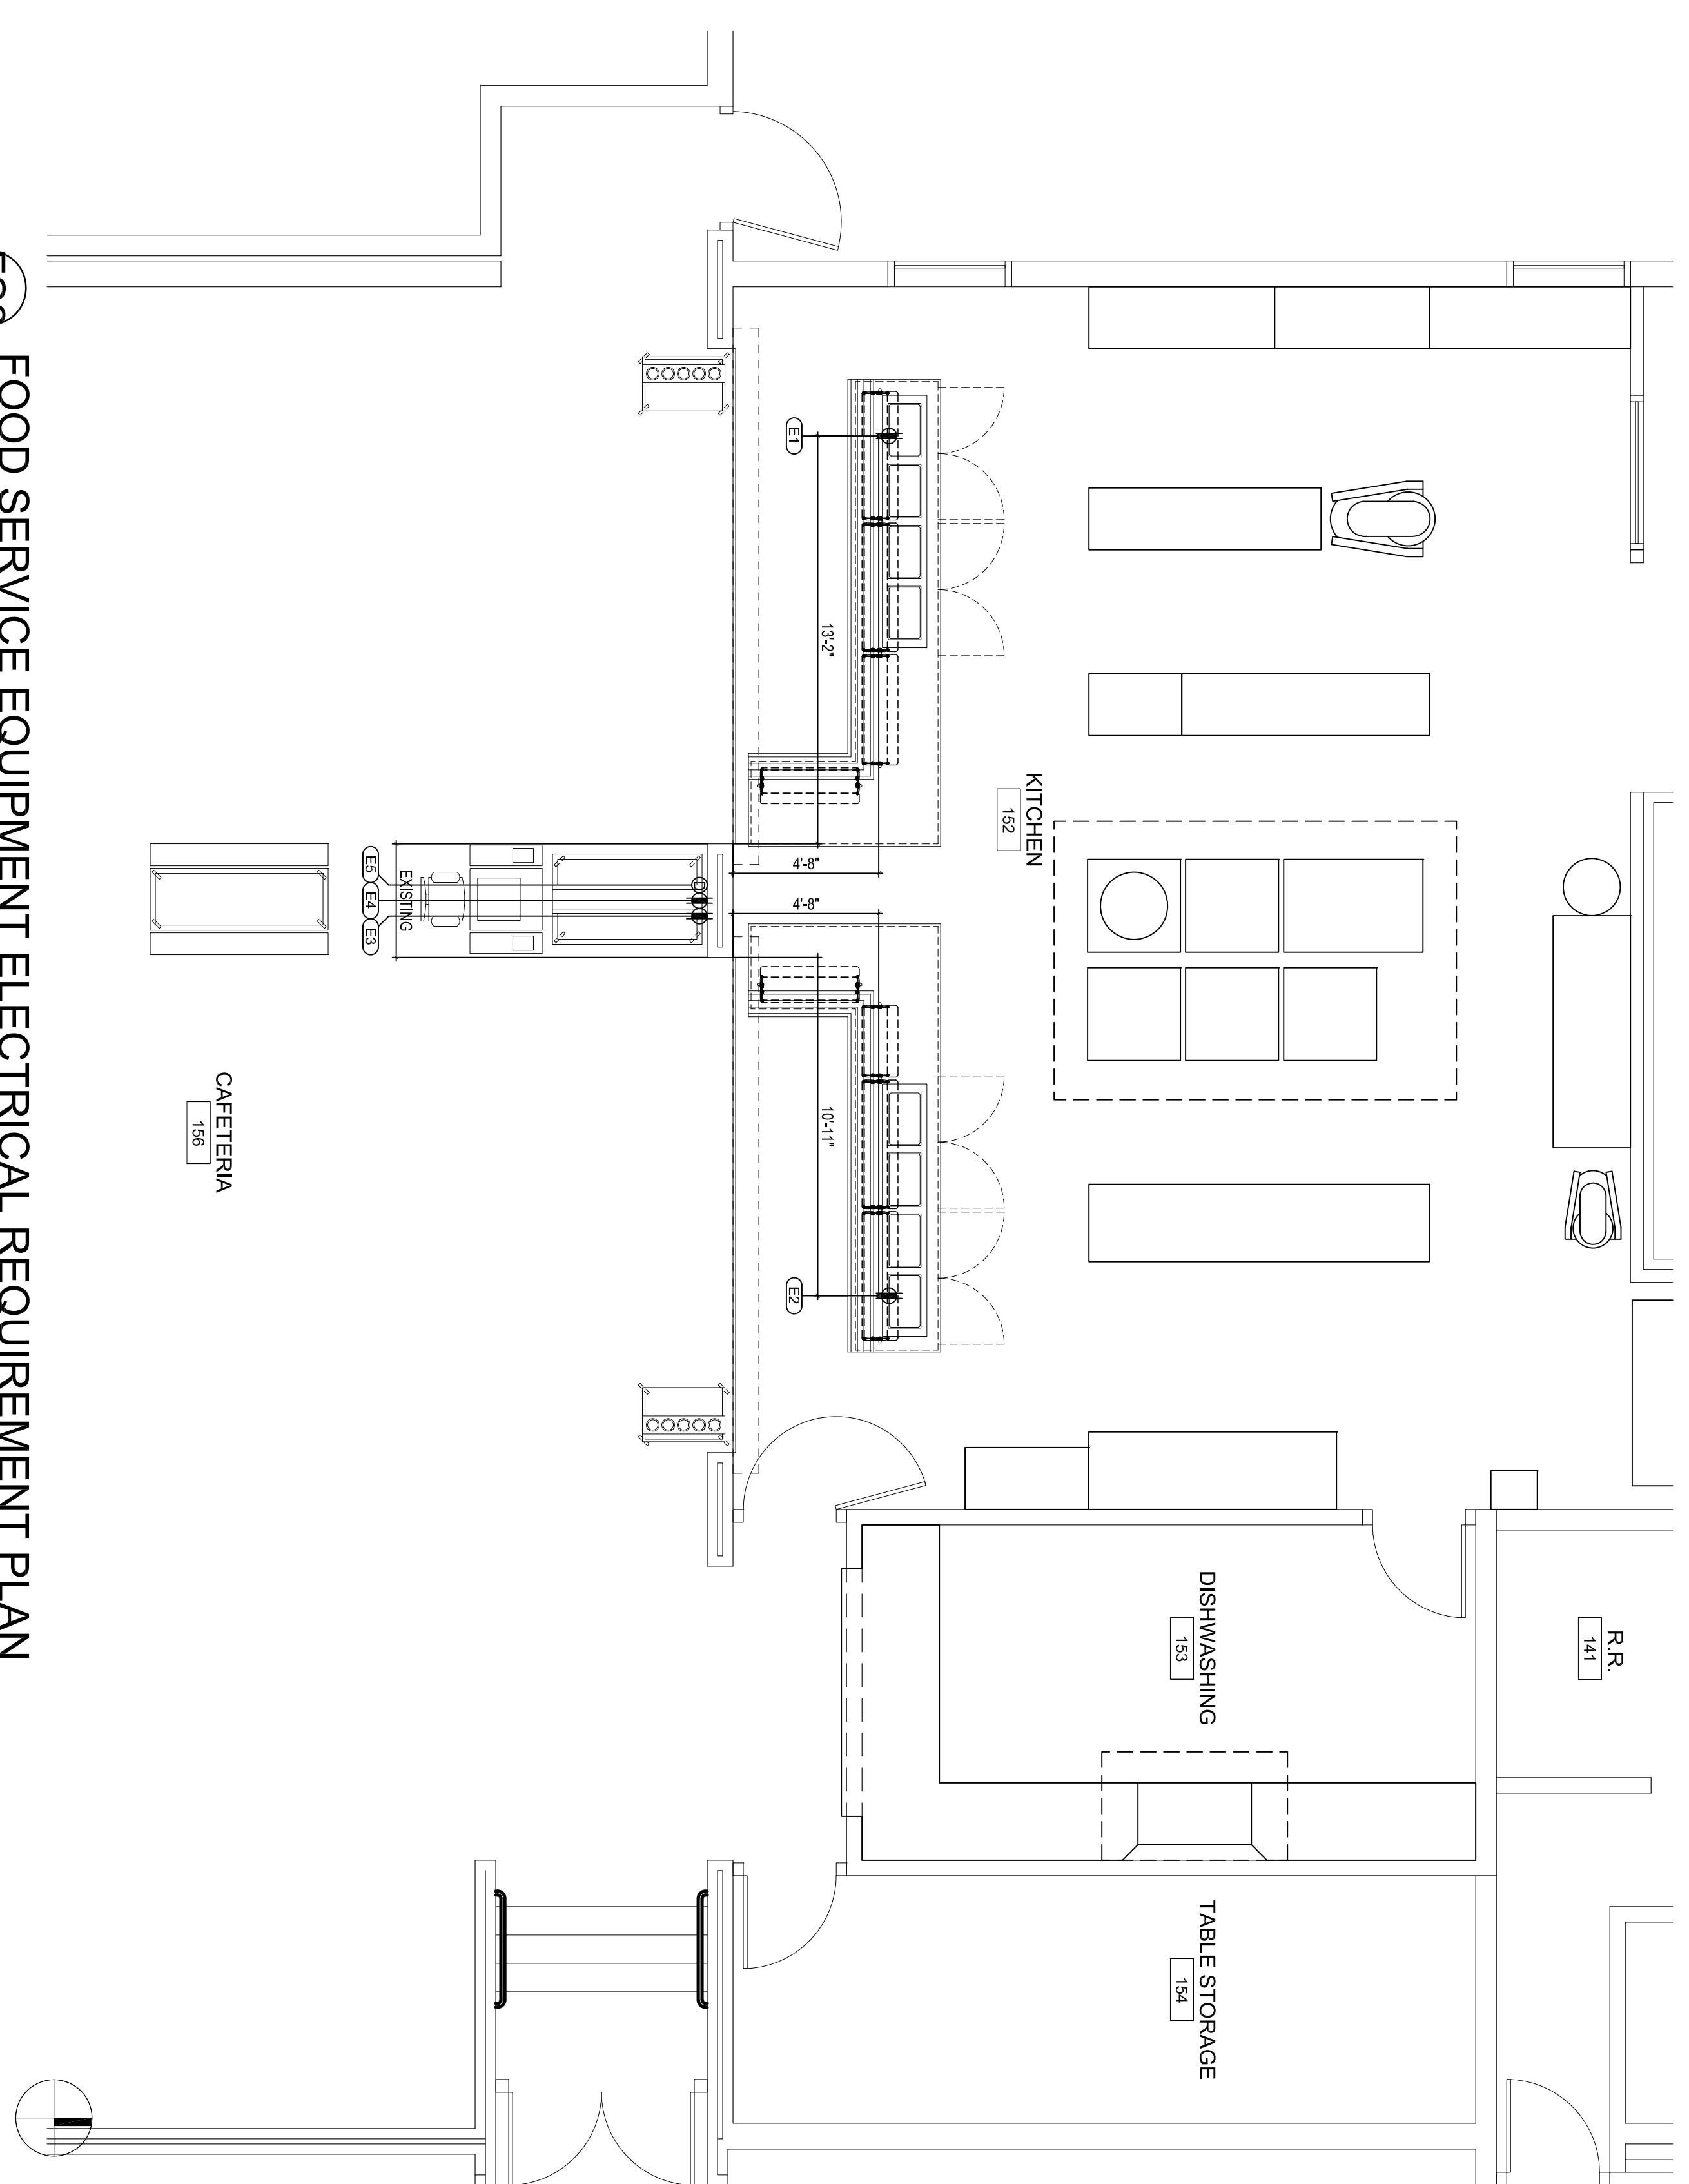

FS2 FOOD SERVICE EQUIPMENT ELECTRICAL REQUIREMENT PLAN
SCALE: 1/4" = 1'-0"

FS1 FOOD SERVICE EQUIPMENT PLUMBING REQUIREMENT PLAN
SCALE: 1/4" = 1'-0"